

SITE PLAN
NOT TO SCALE

SIGNAGE SCHEDULE:

A INTERNALLY ILLUMINATED PYLON SIGN | QTY: ONE (1)



PROPOSED PYLON SIGN (NONE EXISTING)



FEDERAL HEATH
VISUAL COMMUNICATIONS
www.FederalHeath.com

1128 Beville Road, Suite E Daytona Beach, FL 32114
(386) 255-1901 Fax (386) 258-0211

Manufacturing Facilities:
Delaware, OH - Euless, TX - Jacksonville, TX
Oceanside, CA - Racine, WI - Rochester Hills, MI
Office Locations:
Atlanta, GA - Brandon, FL - Indianapolis, IN
Tunica, MS - Daytona Beach, FL - Delaware, OH - Euless, TX
Grafton, WI - Houston, TX - Idaho Falls, ID - Jacksonville, TX
Knoxville, TN - Las Vegas, NV - Louisville, KY
Oceanside, CA - Racine, WI - Rochester Hills, MI - San Antonio, TX
Tampa, FL - Willowbrook, IL - Orlando, FL

Building Quality Signage Since 1901

Revisions:

- R1 BW 5.9.22 Revise size & add option.
- R2 BW 5.12.22 Re-design Main ID cabinet & delete option 2.

Colors Depicted In This Rendering May Not Match Actual Finished Materials. Refer To Product Samples For Exact Color Match.

Client Approval/Date: _____

Landlord Approval/Date: _____

Account Rep: **RANDY GEARLOCK**

Project Manager: **JIM HARVEY**

Drawn By: **JOE KNESTRICK**

Underwriters Laboratories Inc. ELECTRICAL TO USE U.L. LISTED COMPONENTS AND SHALL MEET ALL N.E.C. STANDARDS
ALL ELECTRICAL SIGNS ARE TO COMPLY WITH U.L. 48 AND ARTICLE 600 OF THE N.E.C. STANDARDS, INCLUDING THE PROPER GROUNDING AND BONDING OF ALL SIGNS.

Project / Location:



STORE #
7206 ALCOA ROAD
BRYANT, AR 72022


Job Number: **23-70338-10**

Date: **February 08, 2022**

Sheet Number: **1** of **2**

Design Number: **23-70338-10 R2**

This original drawing is provided as part of a planned project and is not to be exhibited, copied or reproduced without the written permission of Federal Heath Sign Company, LLC or its authorized agent. ©FHSC

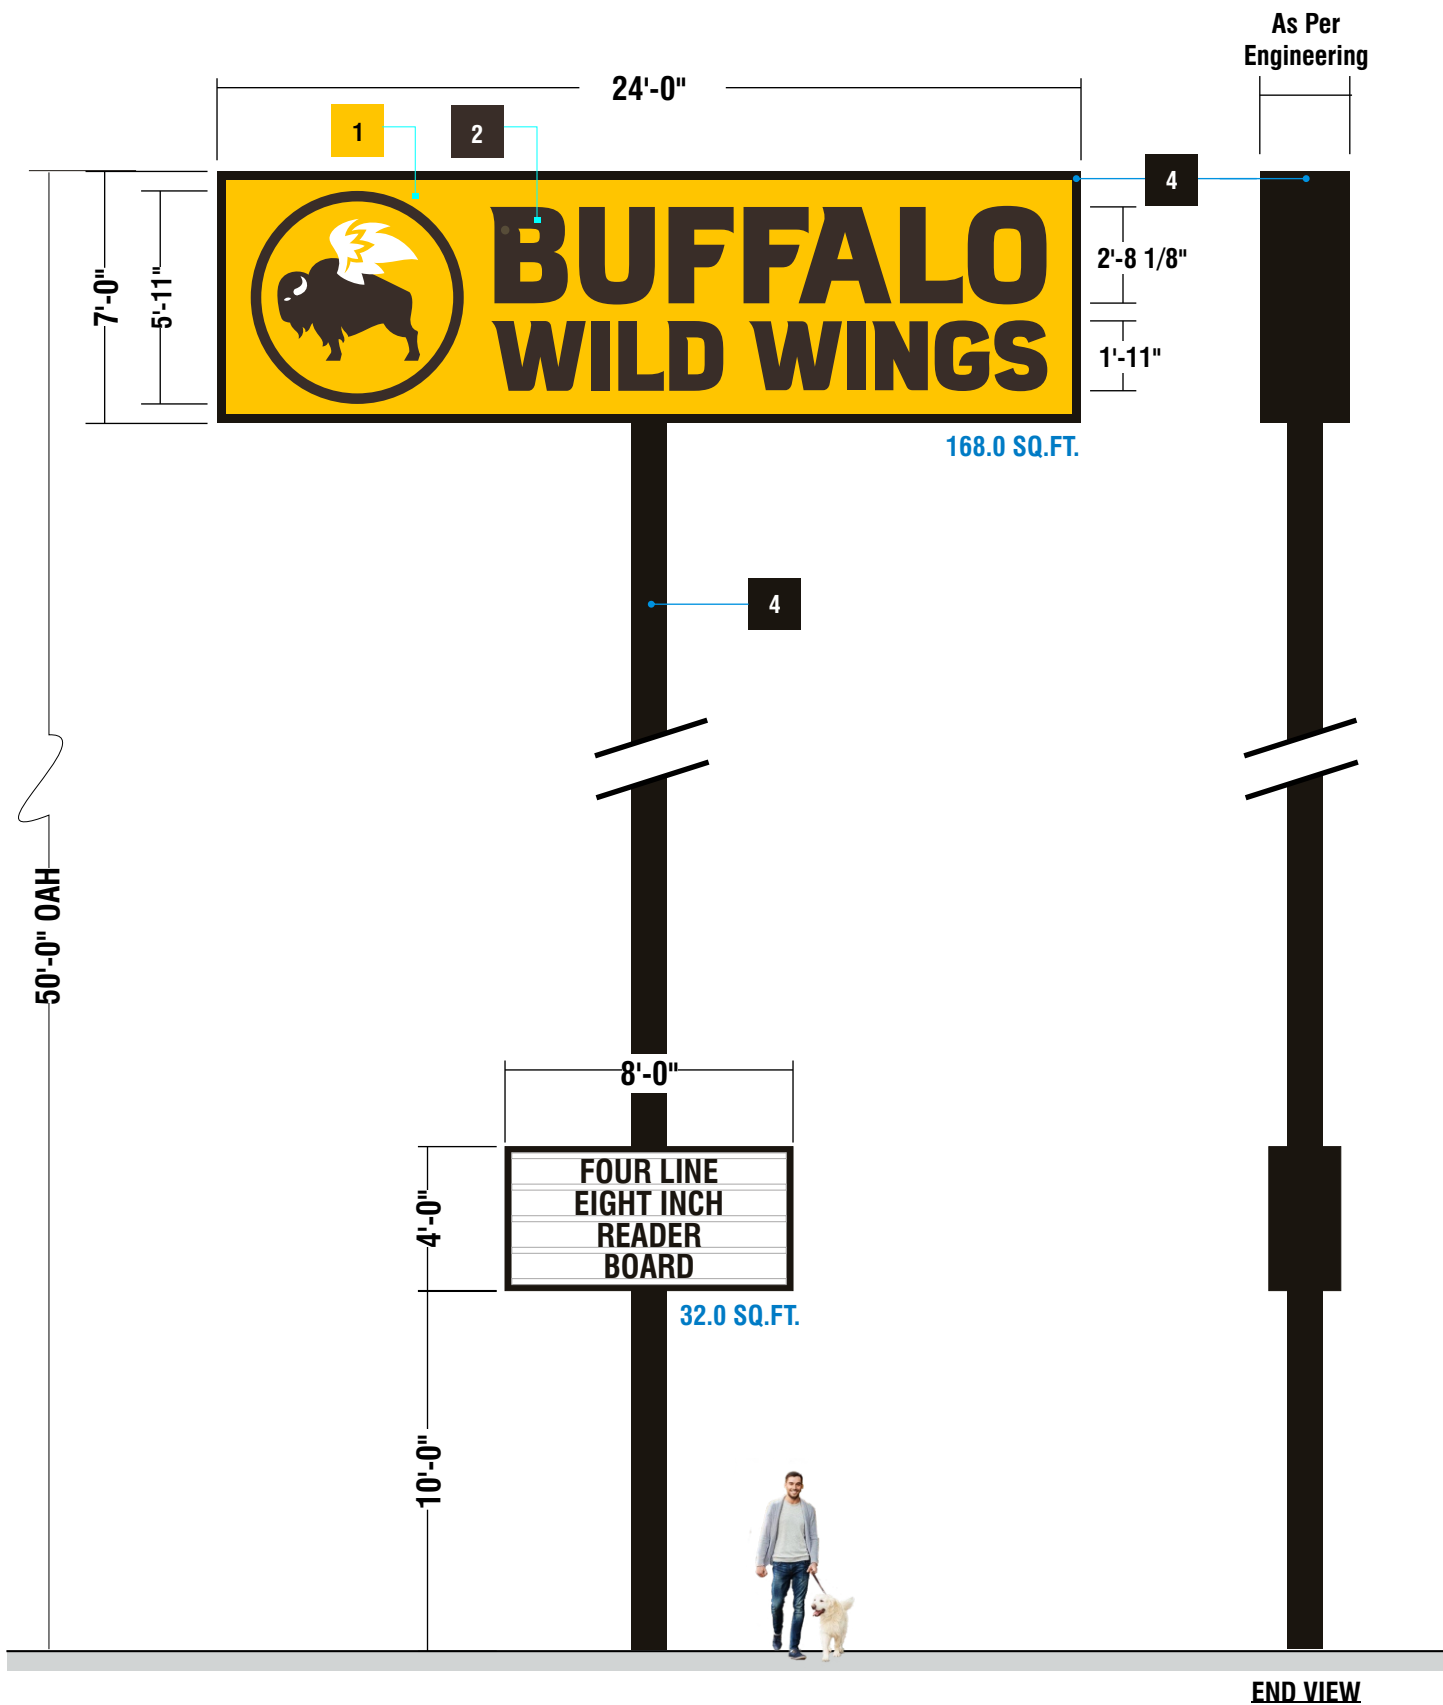

A CUSTOM D/F INTERNALLY ILLUMINATED PYLON SIGN W/ READER BOARD | 200.0 SQ.FT.

SCALE: 3/16" = 1'-0"

MAIN ID CABINET:

CABINET & RETAINERS: ALUMINUM PAINTED BLACK.
FACE: WHITE FLEXIBLE FACE MATERIAL W/ 1ST SURFACE VINYL GRAPHICS.
INTERNAL ILLUMINATION: WHITE LED MODULES.

READER BOARD:

CABINET & RETAINERS: ALUMINUM PAINTED BLACK.
FACE: WHITE POLYCARBONATE.
INTERNAL ILLUMINATION: WHITE LED MODULES.
COPY: (300) 8" BLACK COMMERCIAL FONT ZIP CHANGE LETTERS
W/ STORAGE CABINET & CHANGER ARM.

STEEL SUPPORT:

AS PER ENGINEERING PAINTED BLACK.

STANDARD INSTALL IS TO BE DIRECT PIPE EMBEDMENT INTO CONCRETE FOOTING PER FH ENGINEERING SPECS.

MANUFACTURING WILL PROVIDE A STUB PIPE WITH SIGN CABINETS ONLY IF O.A.H. (CABINET + STUB PIPE) DOES NOT EXCEED 9'-7" MAXIMUM SHIPPING HEIGHT RESTRICTIONS.


ALL SUPPORTING STEEL, INCLUDING STUB PIPE, IF NOT INCLUDED WITH CABINET, TO BE SHIPPED TO INSTALLATION SITE BY AN OUTSIDE SUPPLIER OR BY THE INSTALLATION CONTRACTOR, AS DETERMINED BY PROJECT MANAGEMENT.

NOTE: UPON CUSTOMER ACCEPTANCE, FEDERAL HEATH ENGINEERING DEPARTMENT WILL PROVIDE FABRICATION DRAWINGS & ENGINEERED SEAL DRAWINGS IF REQUIRED
THIS DRAWING IS FOR PRESENTATION ONLY

INSTALLATION OF THIS SIGN SHALL CONFORM TO ARTICLE 600 OF THE NEC, UL48, AND OR OTHER APPLICABLE LOCAL CODES, INCLUDING PROPER GROUNDING AND BONDING OF SIGN.

LOCATION OF DISCONNECT SWITCH AFTER INSTALLATION SHALL COMPLY WITH ARTICLE 600.6(A) OF THE NEC.

ENGINEERING REQUIRED

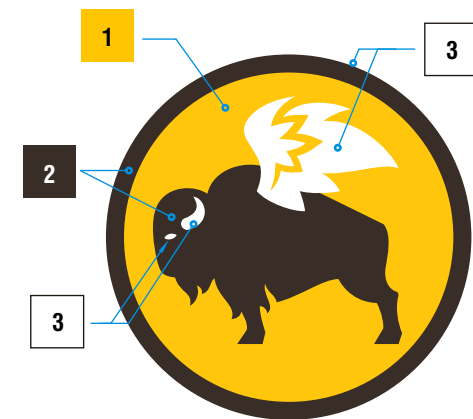

Color Breakdown | Logo

PMS 7548c 2500-125 Golden Yellow	PMS 440c 2500-69 Duronodic	100 % White	100 % Black
1	2	3	4



VISUAL COMMUNICATIONS
www.FederalHeath.com

1128 Beville Road, Suite E Daytona Beach, FL 32114
(386) 255-1901 Fax (386) 258-0211

Manufacturing Facilities:
Delaware, OH - Euless, TX - Jacksonville, TX
Oceanside, CA - Racine, WI - Rochester Hills, MI
Office Locations:
Atlanta, GA - Brandon, FL - Indianapolis, IN
Tunica, MS - Daytona Beach, FL - Delaware, OH - Euless, TX
Grafton, WI - Houston, TX - Idaho Falls, ID - Jacksonville, TX
Knoxville, TN - Las Vegas, NV - Louisville, KY
Oceanside, CA - Racine, WI - Rochester Hills, MI - San Antonio, TX
Tampa, FL - Willowbrook, IL - Orlando, FL

Building Quality Signage Since 1901

Revisions:

- R1 BW 5.9.22 Revise size & add option.
- R2 BW 5.12.22 Re-design Main ID cabinet & delete option 2.

Colors Depicted In This Rendering May Not Match Actual Finished Materials. Refer To Product Samples For Exact Color Match.

Client Approval/Date: _____

Landlord Approval/Date: _____

Account Rep: RANDY GEARLOCK

Project Manager: JIM HARVEY

Drawn By: JOE KNESTRICK

UL Underwriters Laboratories Inc. nfc ELECTRICAL TO USE U.L. LISTED COMPONENTS AND SHALL MEET ALL N.E.C. STANDARDS
ALL ELECTRICAL SIGNS ARE TO COMPLY WITH U.L. 48 AND ARTICLE 600 OF THE N.E.C. STANDARDS, INCLUDING THE PROPER GROUNDING AND BONDING OF ALL SIGNS.

Project / Location:



STORE #
7206 ALCOA ROAD
BRYANT, AR 72022

Job Number: 23-70338-10

Date: February 08, 2022

Sheet Number: 2 of 2

Design Number: 23-70338-10 R2

This original drawing is provided as part of a planned project and is not to be exhibited, copied or reproduced without the written permission of Federal Heath Sign Company, LLC or its authorized agent. ©FHSC