
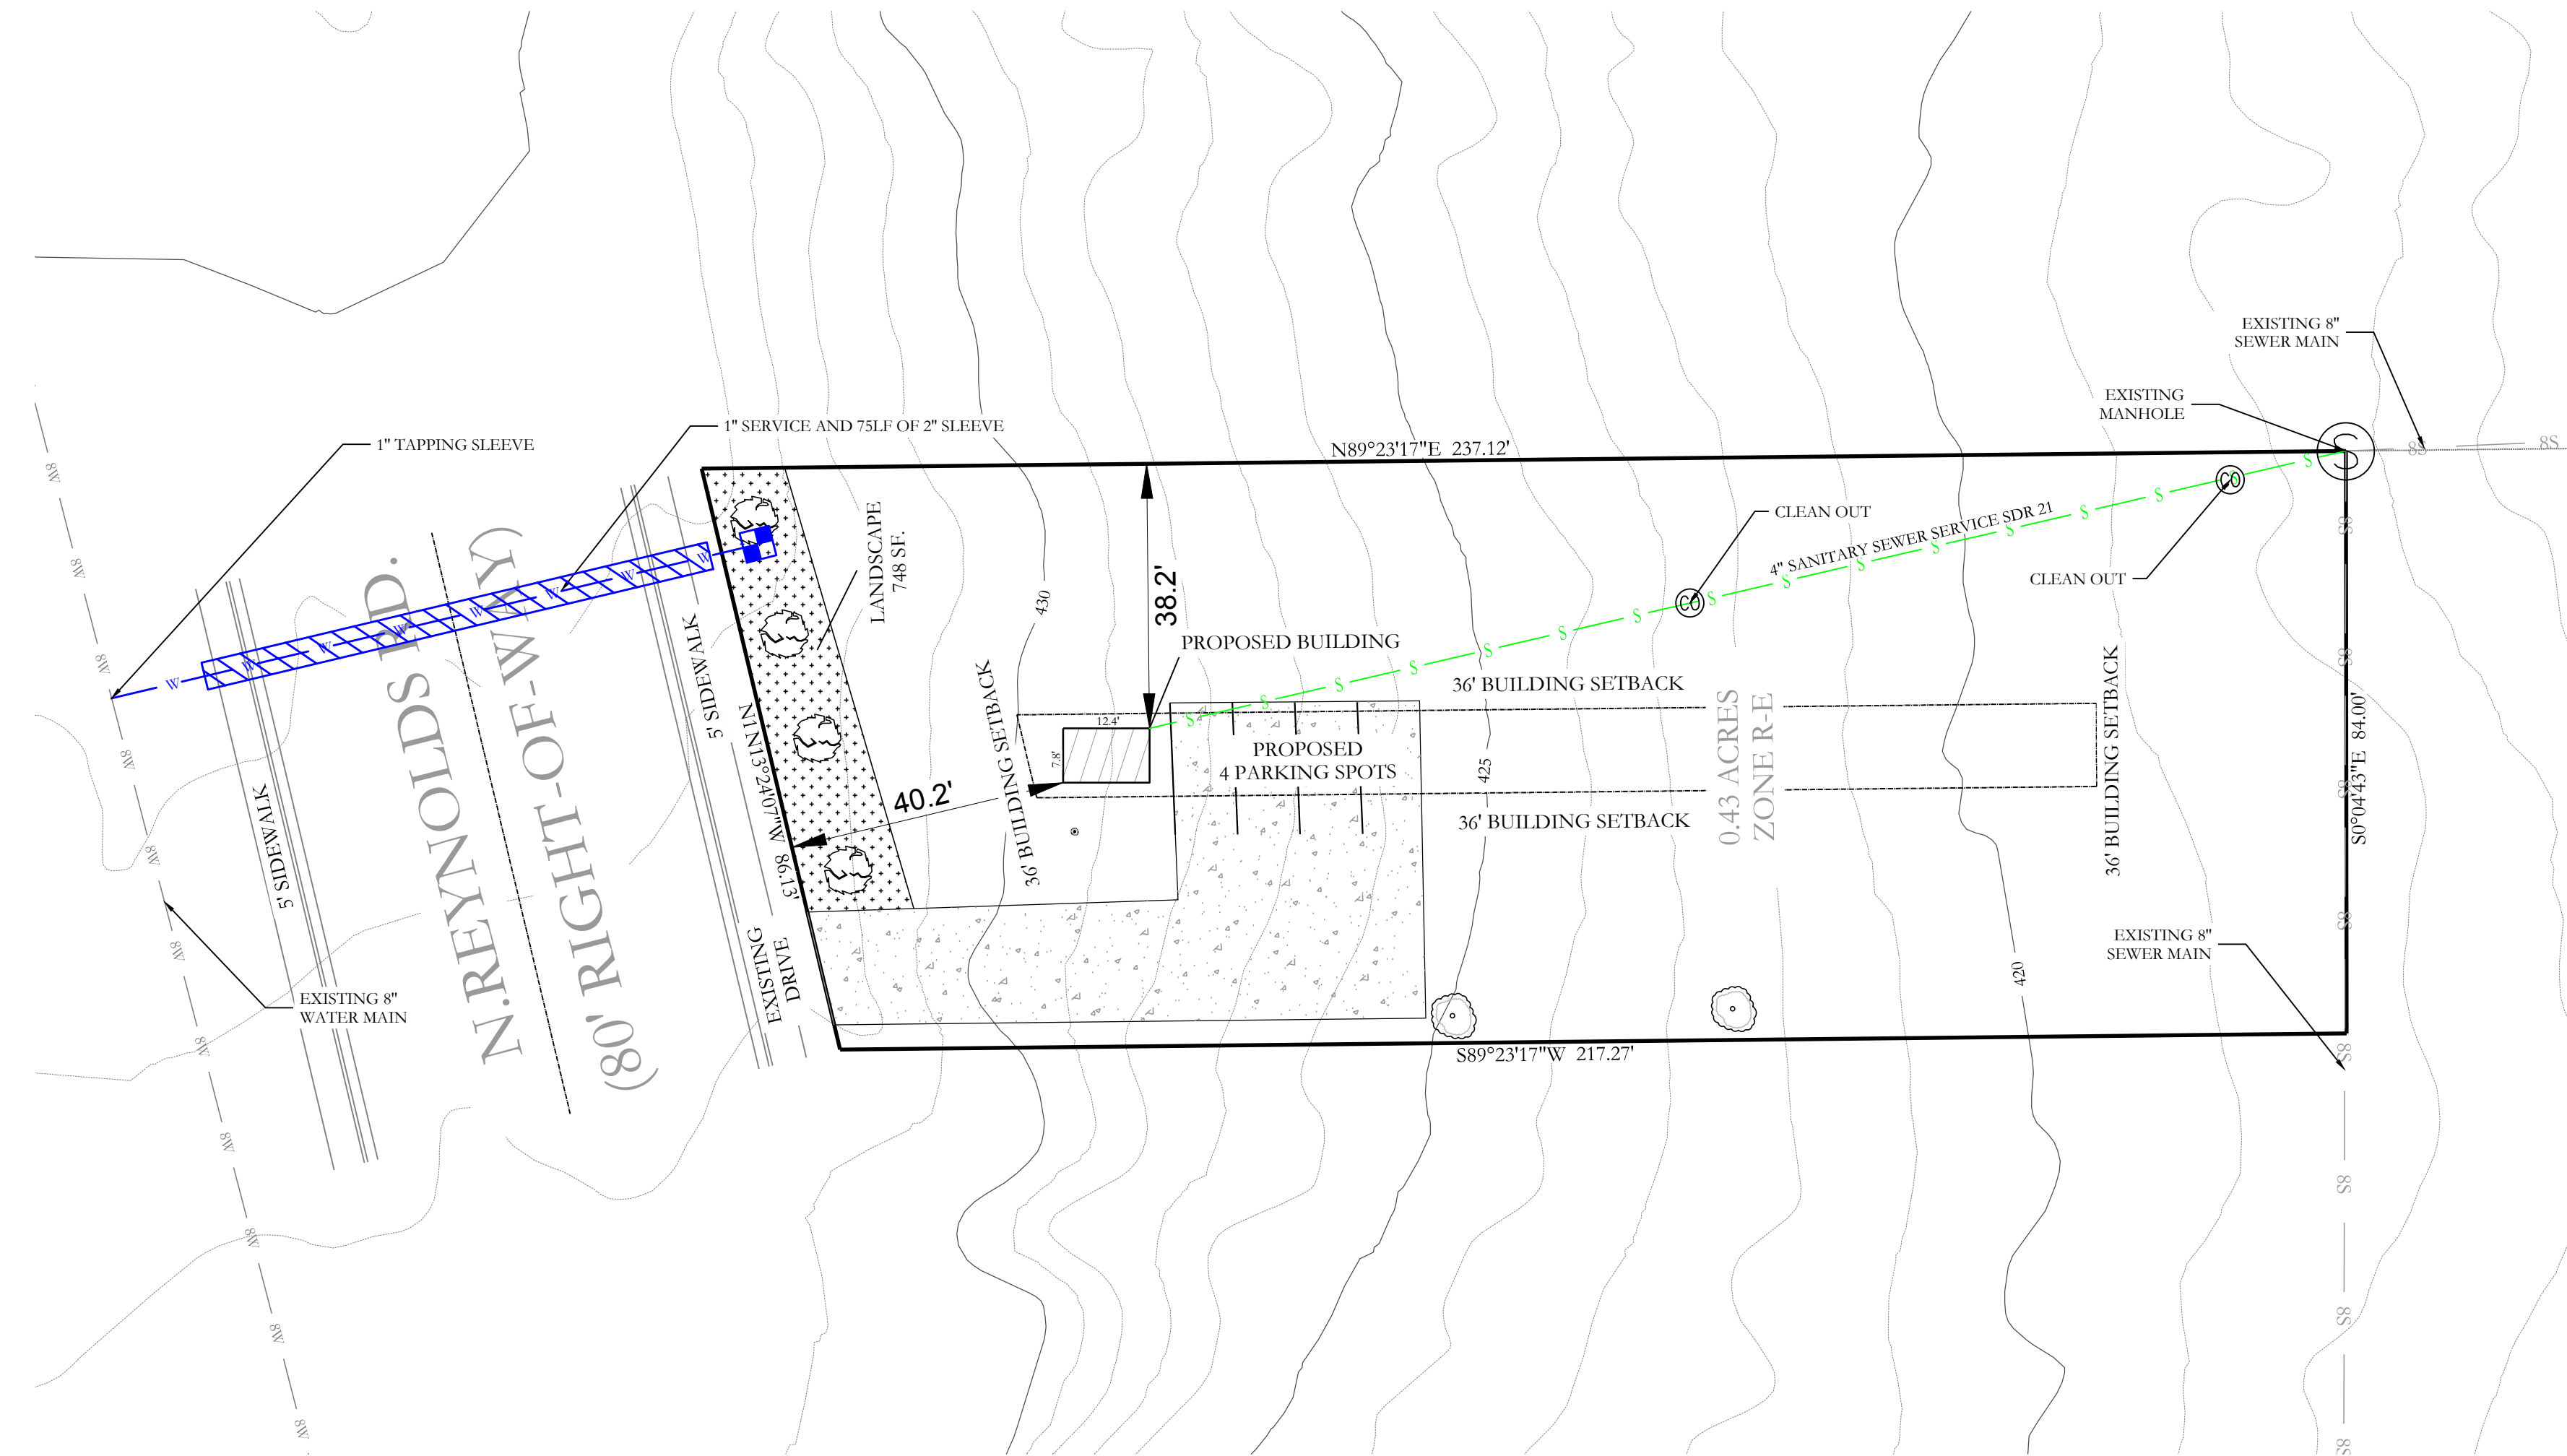
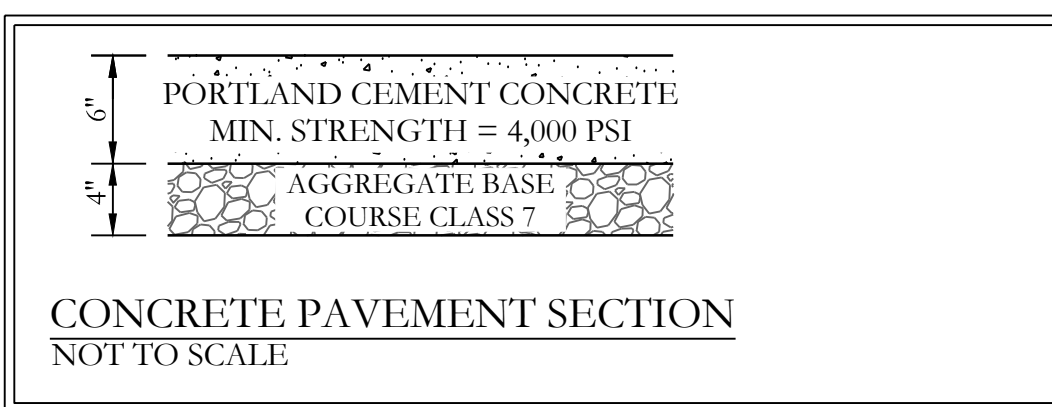


CONTACTS UTILITIES AND CITY AND STATE AGENCIES			
AGENCY	TITLE	NAME	CONTACT
BRYANT PUBLIC WORKS	DIRECTOR	TIM FOURNIER	501-366-0343
BRYANT PUBLIC WORKS	ENGINEER	TED TAYLOR	501-366-0343
BRYANT WATER	INSPECTOR	JOE HENRY	501-246-0516
ENTERGY	CONTACT	JEREMY HENDERSON	800-368-3749
CENTERPOINT (GAS)	CONTACT	ADAM GOBER	501-541-7509
ARDOT	PERMIT OFFICER DISTRICT SIX	CORY SUTTON	501 551-5207

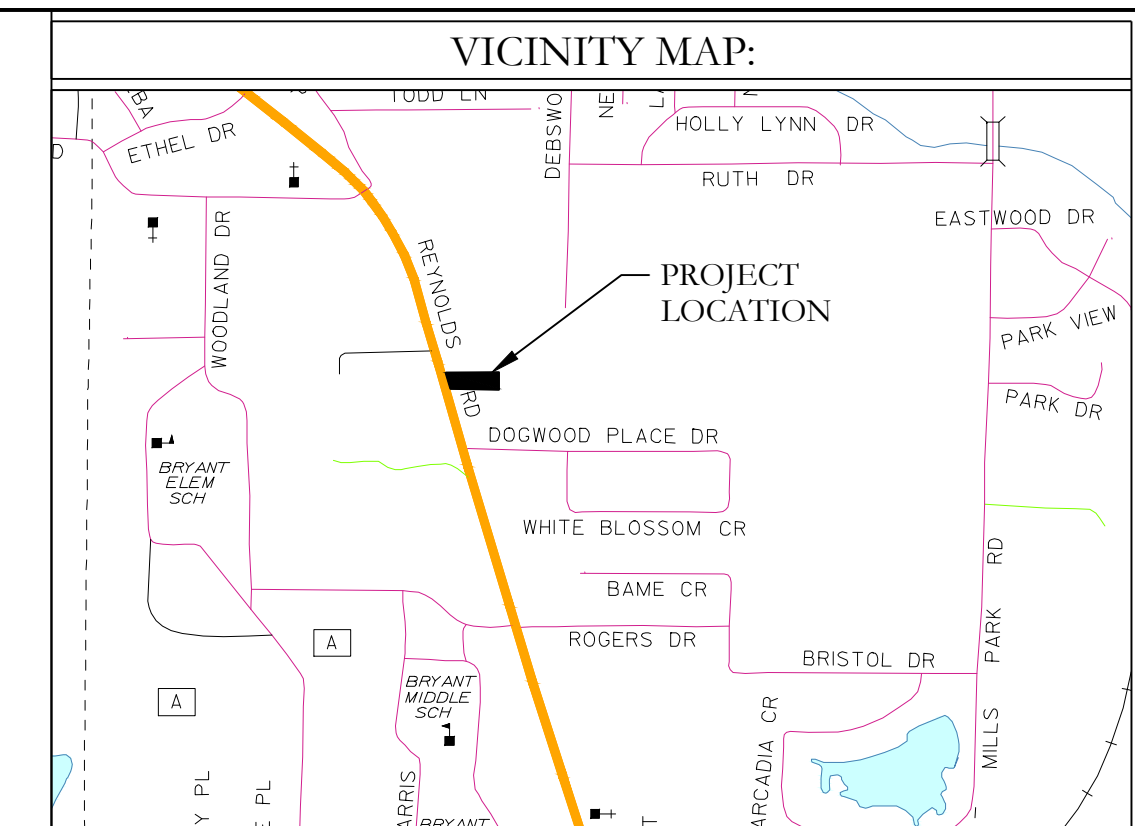

WATER LEGEND

- FIRE HYDRANT
- BLOW OFF
- PROPOSED GATE VALVE
- PROPOSED 1" WATER METER
- PROPOSED WATER SERVICE

SEWER LEGEND


- SANITARY SEWER MANHOLE EXIST.
- CLEANOUT
- PROPOSED SEWER SERVICE

WATER NOTES

- ALL WATER INFRASTRUCTURE SHALL BE CONSTRUCTED IN ACCORDANCE WITH THE CITY OF BRYANT "STANDARD SPECIFICATIONS FOR DESIGN AND CONSTRUCTION OF WATER LINES AND SEWER LINES, 2015 EDITION".
- CASING SPACERS SHALL BE STAINLESS STEEL.
- FIXTURE- 1 HAND SHOWER
- DAILY DEMAND- 500 Gallon/Day

SEWER NOTES

- ALL SEWER INFRASTRUCTURE SHALL BE CONSTRUCTED IN ACCORDANCE WITH THE CITY OF BRYANT "STANDARD SPECIFICATIONS FOR DESIGN AND CONSTRUCTION OF WATER LINES AND SEWER LINES, 2015 EDITION".
- INFORMATION ON DEPTH OF EXISTING TIE IN MANHOLE AND DOWNSTREAM MH OBTAINED FROM EFS EDGE GIS DATA.
- CASING SPACERS SHALL BE STAINLESS STEEL.

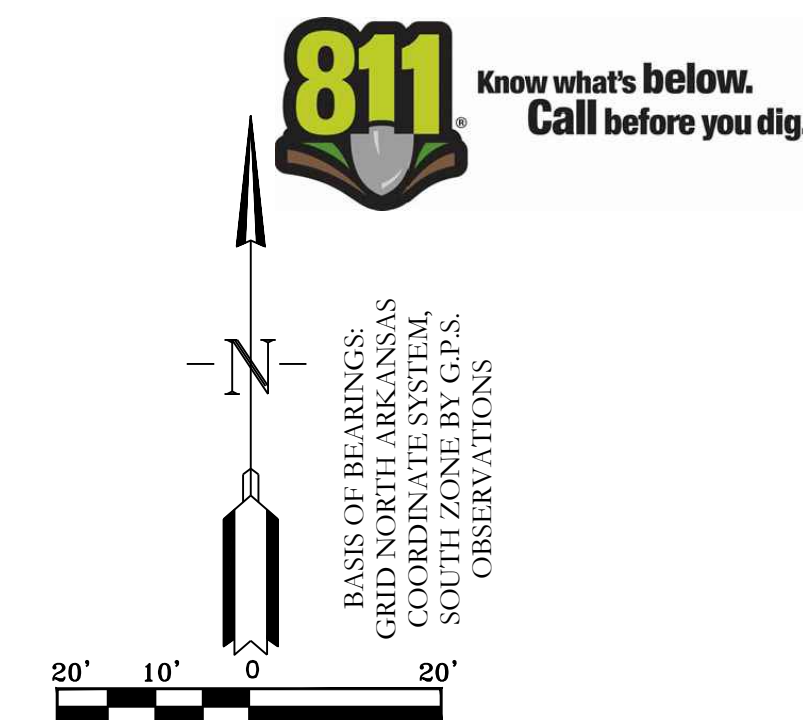

CIVIL ENGINEER
 HOPE CONSULTING INC
 117 S. MARKET STREET
 BENTON, AR 72015
 CONTACT: WILLIAM W MCFADDEN
 PHONE: 504-315-2626
 EMAIL: kazi@hopeconsulting.com

HOPE CONSULTING ENGINEERS - SURVEYORS 117 S. Market Street, Benton, Arkansas 72015
 PH. (501)315-2626 FAX (501) 315-0024 www.hopeconsulting.com

FOR USE AND BENEFIT OF:
DENNY CONSTRUCTION, LLC.

UTILITY PLAN
 ALL PAWS PET WASH- BRYANT
 BRYANT, ARKANSAS

DATE:	08-12-2022	C.A.D. BY:		DRAWING NUMBER:	
REVISED:		CHECKED BY:		22-0982	
SHEET:	C-1.0	SCALE:			
500	01S	14W	0 27 120	62	1664

K:\LAND PROJECTS\2014\COMMERCIAL\2022\22-0982 ALL PAWS PET WASH BRYANT SURVEY DWG\22-0982 ALL PAWS PET WASH BRYANT.DWG